

NOT FOR CONSTRUCTION - FOR DISCUSSION PURPOSES ONLY




DRAFTED:

DESIGNED:

ROUNDBOUT EVALUATION


SITE 1 & 2

01/25/24 | 11:51 AM | RICHARDZ H:\P\PROJECTS\201616.04 (LANDRUM BROWN) POS SAMP\SD13 - FUTURE FORECASTING\WSDOT COMMENT WORK\PRELIMINARY ICESIGNAL CONCEPT\DES MOINES MEMORIAL DR S-012424.DWG

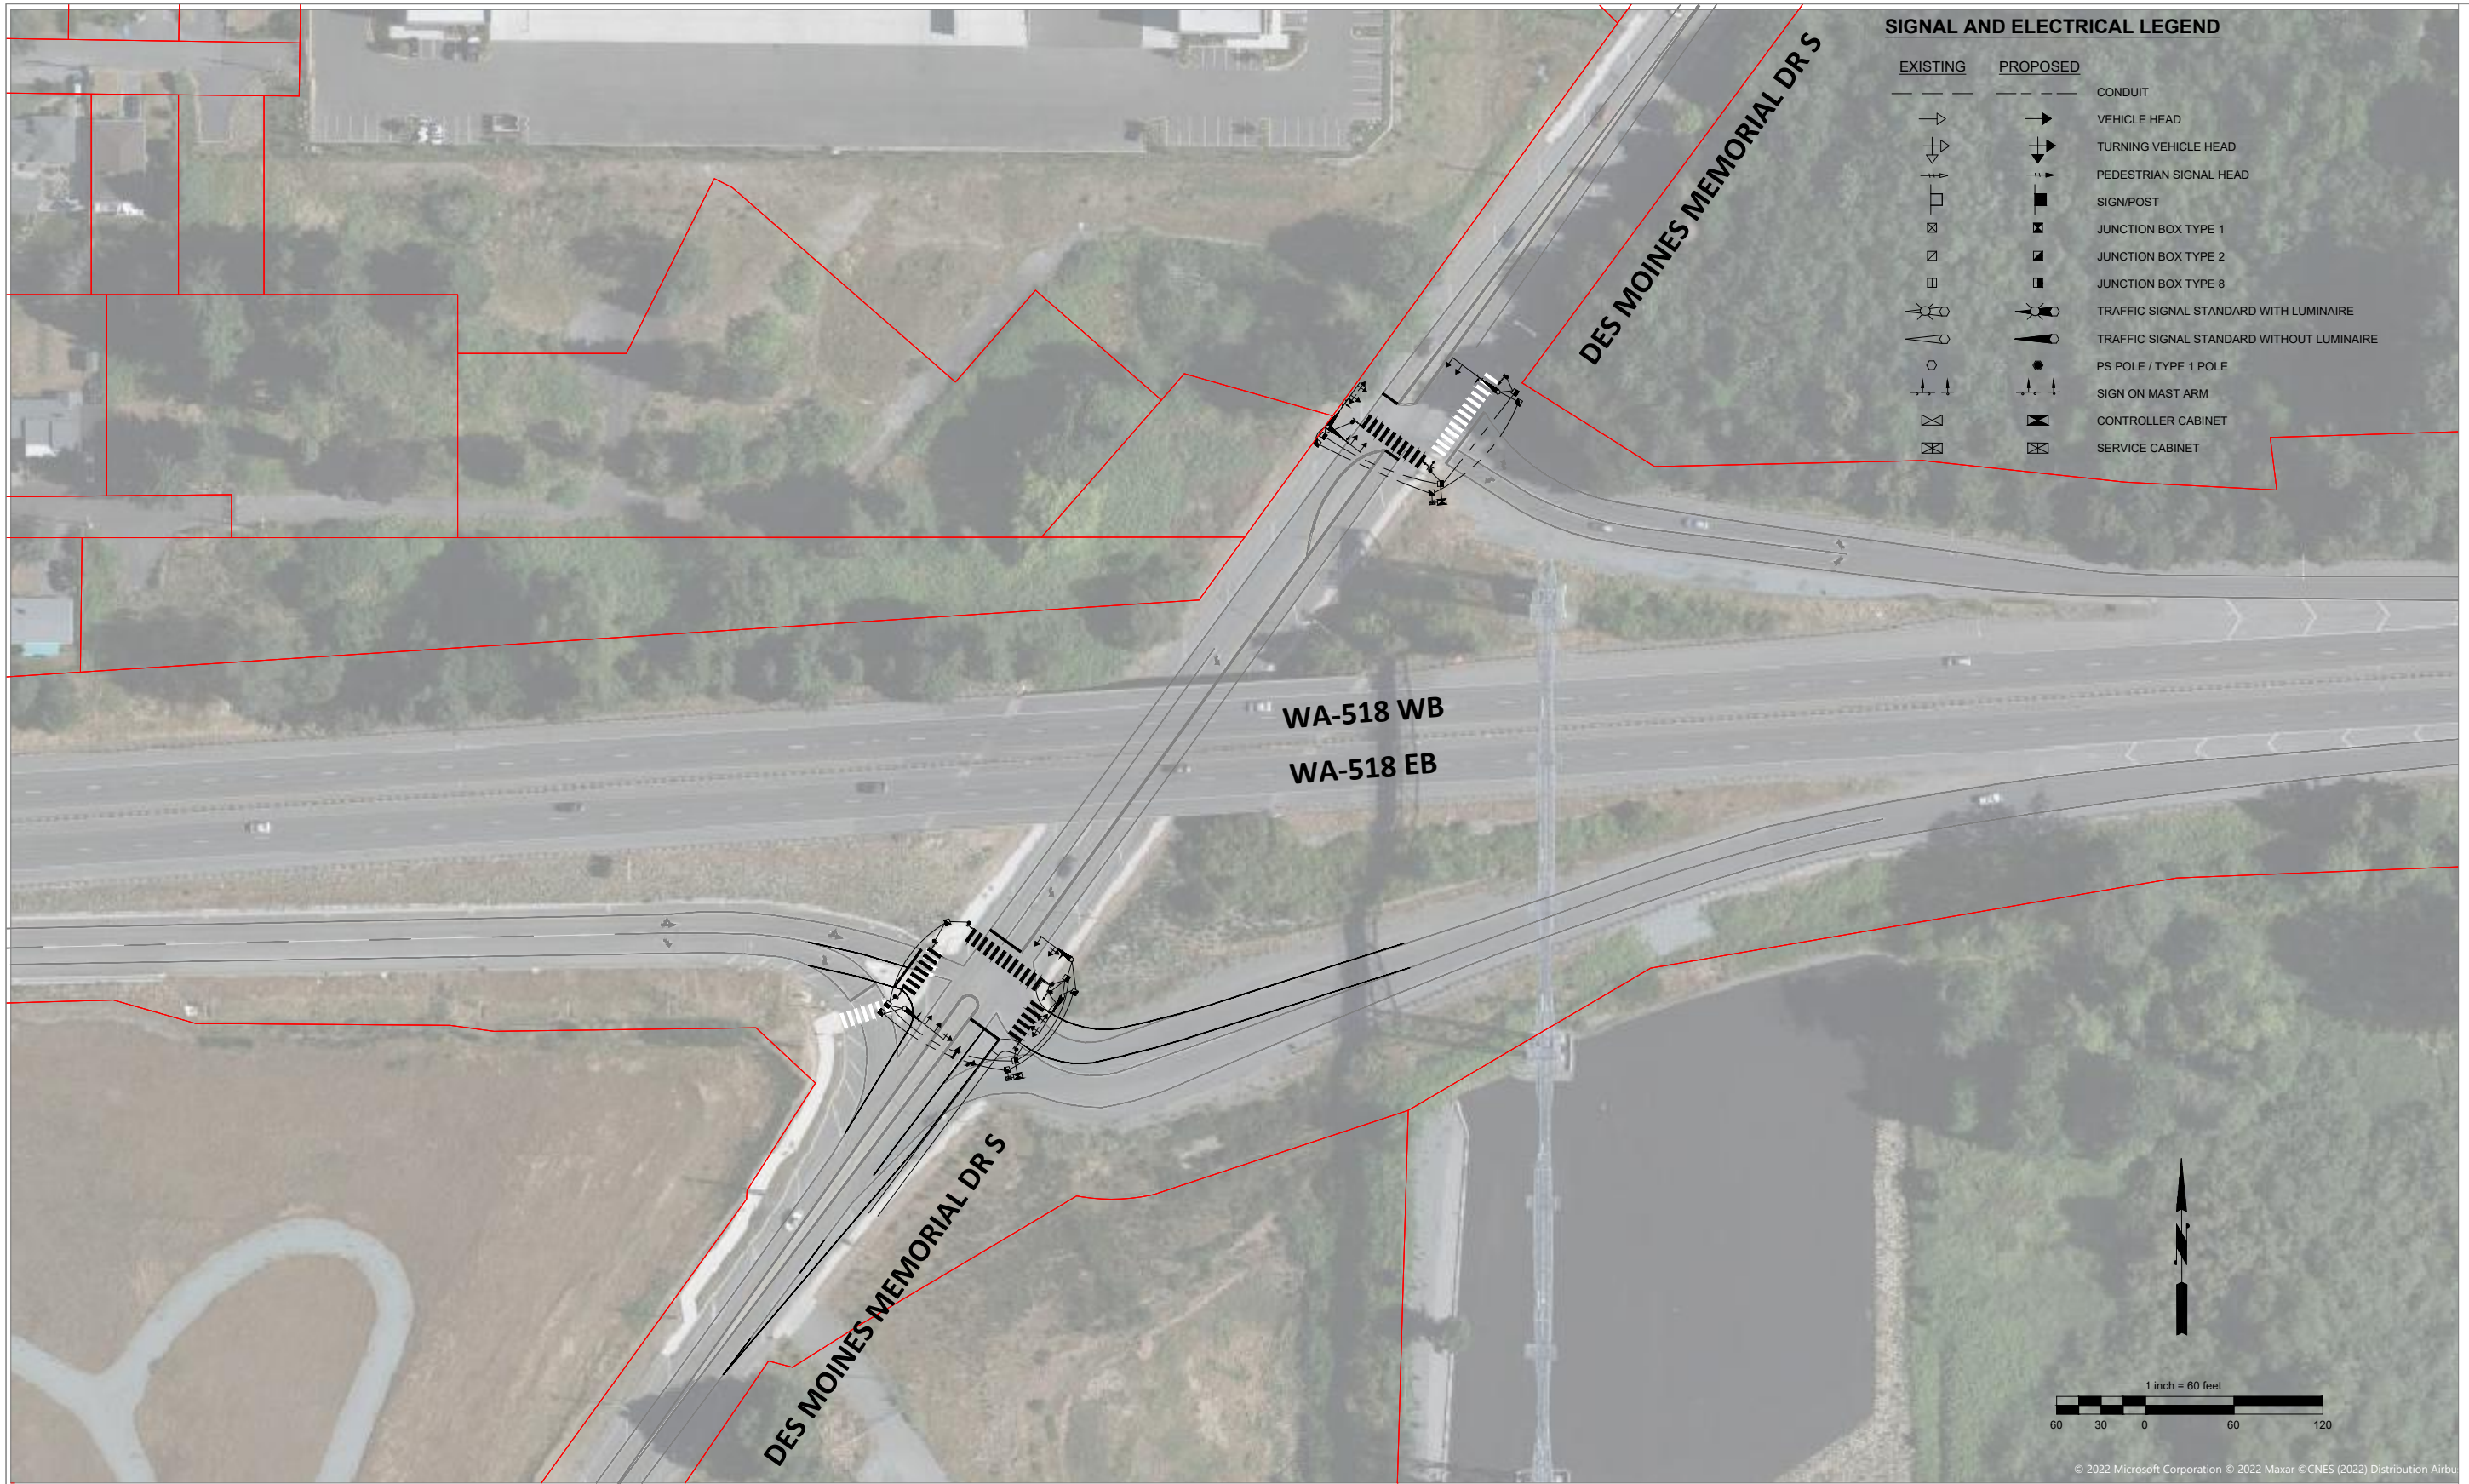

SIGNAL AND ELECTRICAL LEGEND

EXISTING	PROPOSED	
		CONDUIT
		VEHICLE HEAD
		TURNING VEHICLE HEAD
		PEDESTRIAN SIGNAL HEAD
		SIGN/POST
		JUNCTION BOX TYPE 1
		JUNCTION BOX TYPE 2
		JUNCTION BOX TYPE 8
		TRAFFIC SIGNAL STANDARD WITH LUMINAIRE
		TRAFFIC SIGNAL STANDARD WITHOUT LUMINAIRE
		PS POLE / TYPE 1 POLE
		SIGN ON MAST ARM
		CONTROLLER CABINET
		SERVICE CABINET

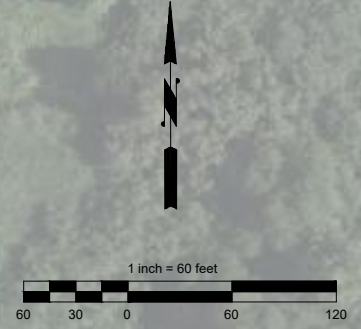


© 2022 Microsoft Corporation © 2022 Maxar © CNES (2022) Distribution Airbu

NOT FOR CONSTRUCTION - FOR DISCUSSION PURPOSES ONLY

NO.	DATE	BY	APPR.	REVISIONS

R. ZHONG 12/06/23
 DESIGNED BY DATE
 R. ZHONG 12/06/23
 DRAWN BY DATE
 M. AHMED 12/11/23
 CHECKED BY DATE

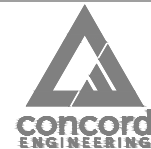

SAMP Preliminary ICE Signal Concept

SHEET NAME SHT ____ OF ____ X